

GROUND FLOOR PLAN


AT
THE GENIE LOUNGE
52 ALBERT PLACE
PETERBOROUGH
PE1 1DD

N. P. DRAYTON BSc, MRB
200 FRODOBAY ROAD,
PETERBOROUGH,
PE1 4HG
phone 01753 20117
fax 01753 20100

Scale: 1 : 100

Date: MARCH 2002

Drawing Number:
21.086

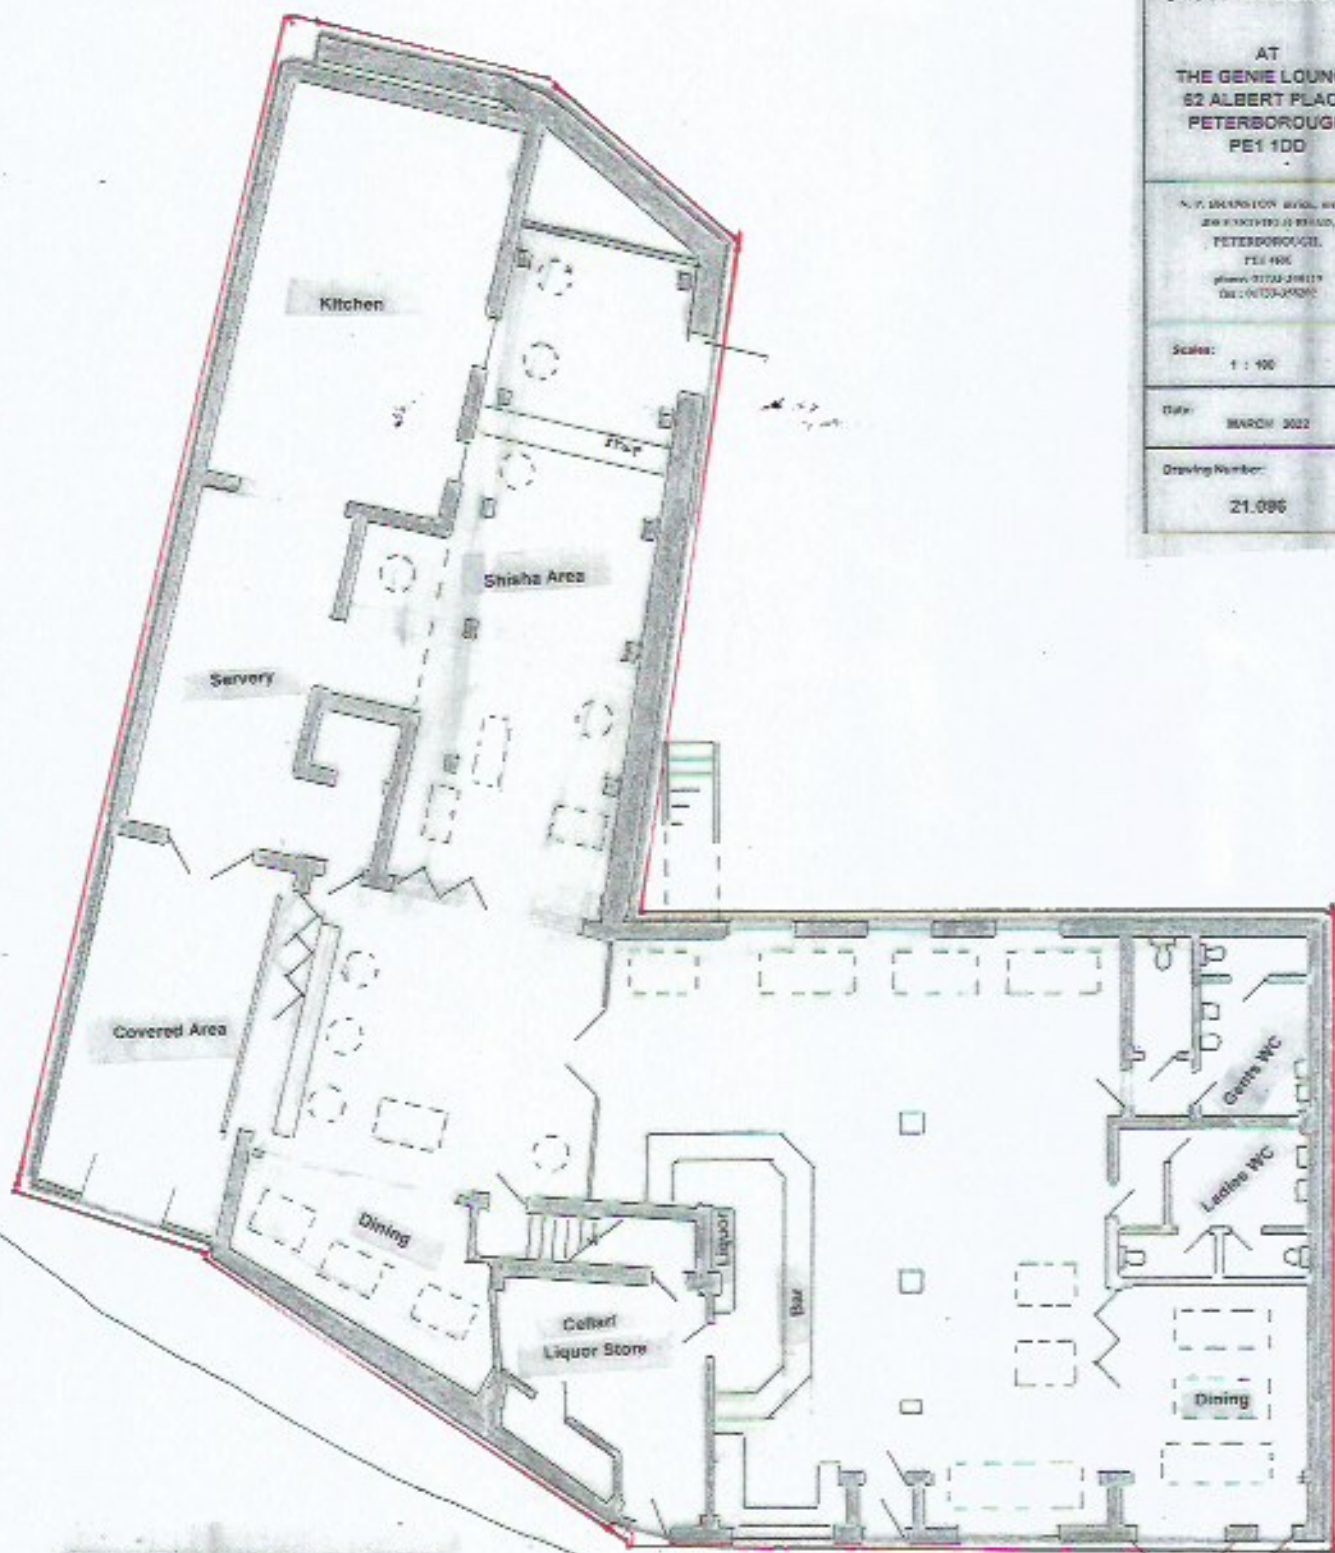

GROUND FLOOR PLAN 1:100

SCALE 1:100

